


# WALLACE LAKE ESTATES

## UNIT NO. 1

### SEWER IMPROVEMENTS

#### INDEX OF SHEETS

- S - 1 COVER SHEET & SEWER SCHEMATIC
  - S - 2 SEWER MASTER PLAN
  - S - 3 SEWER PROFILES
  - S - 4 SEWER PROFILES
  - S - 5 SEWER TREATMENT AREA
  - S - 6 STORAGE RESERVOIR & SPRAY FIELD
  - S - 7 SEWER DETAILS
  - S - 8 SEWER DETAILS
- TREATMENT & PUMP STATION  
UNDER SEPARATE COVER

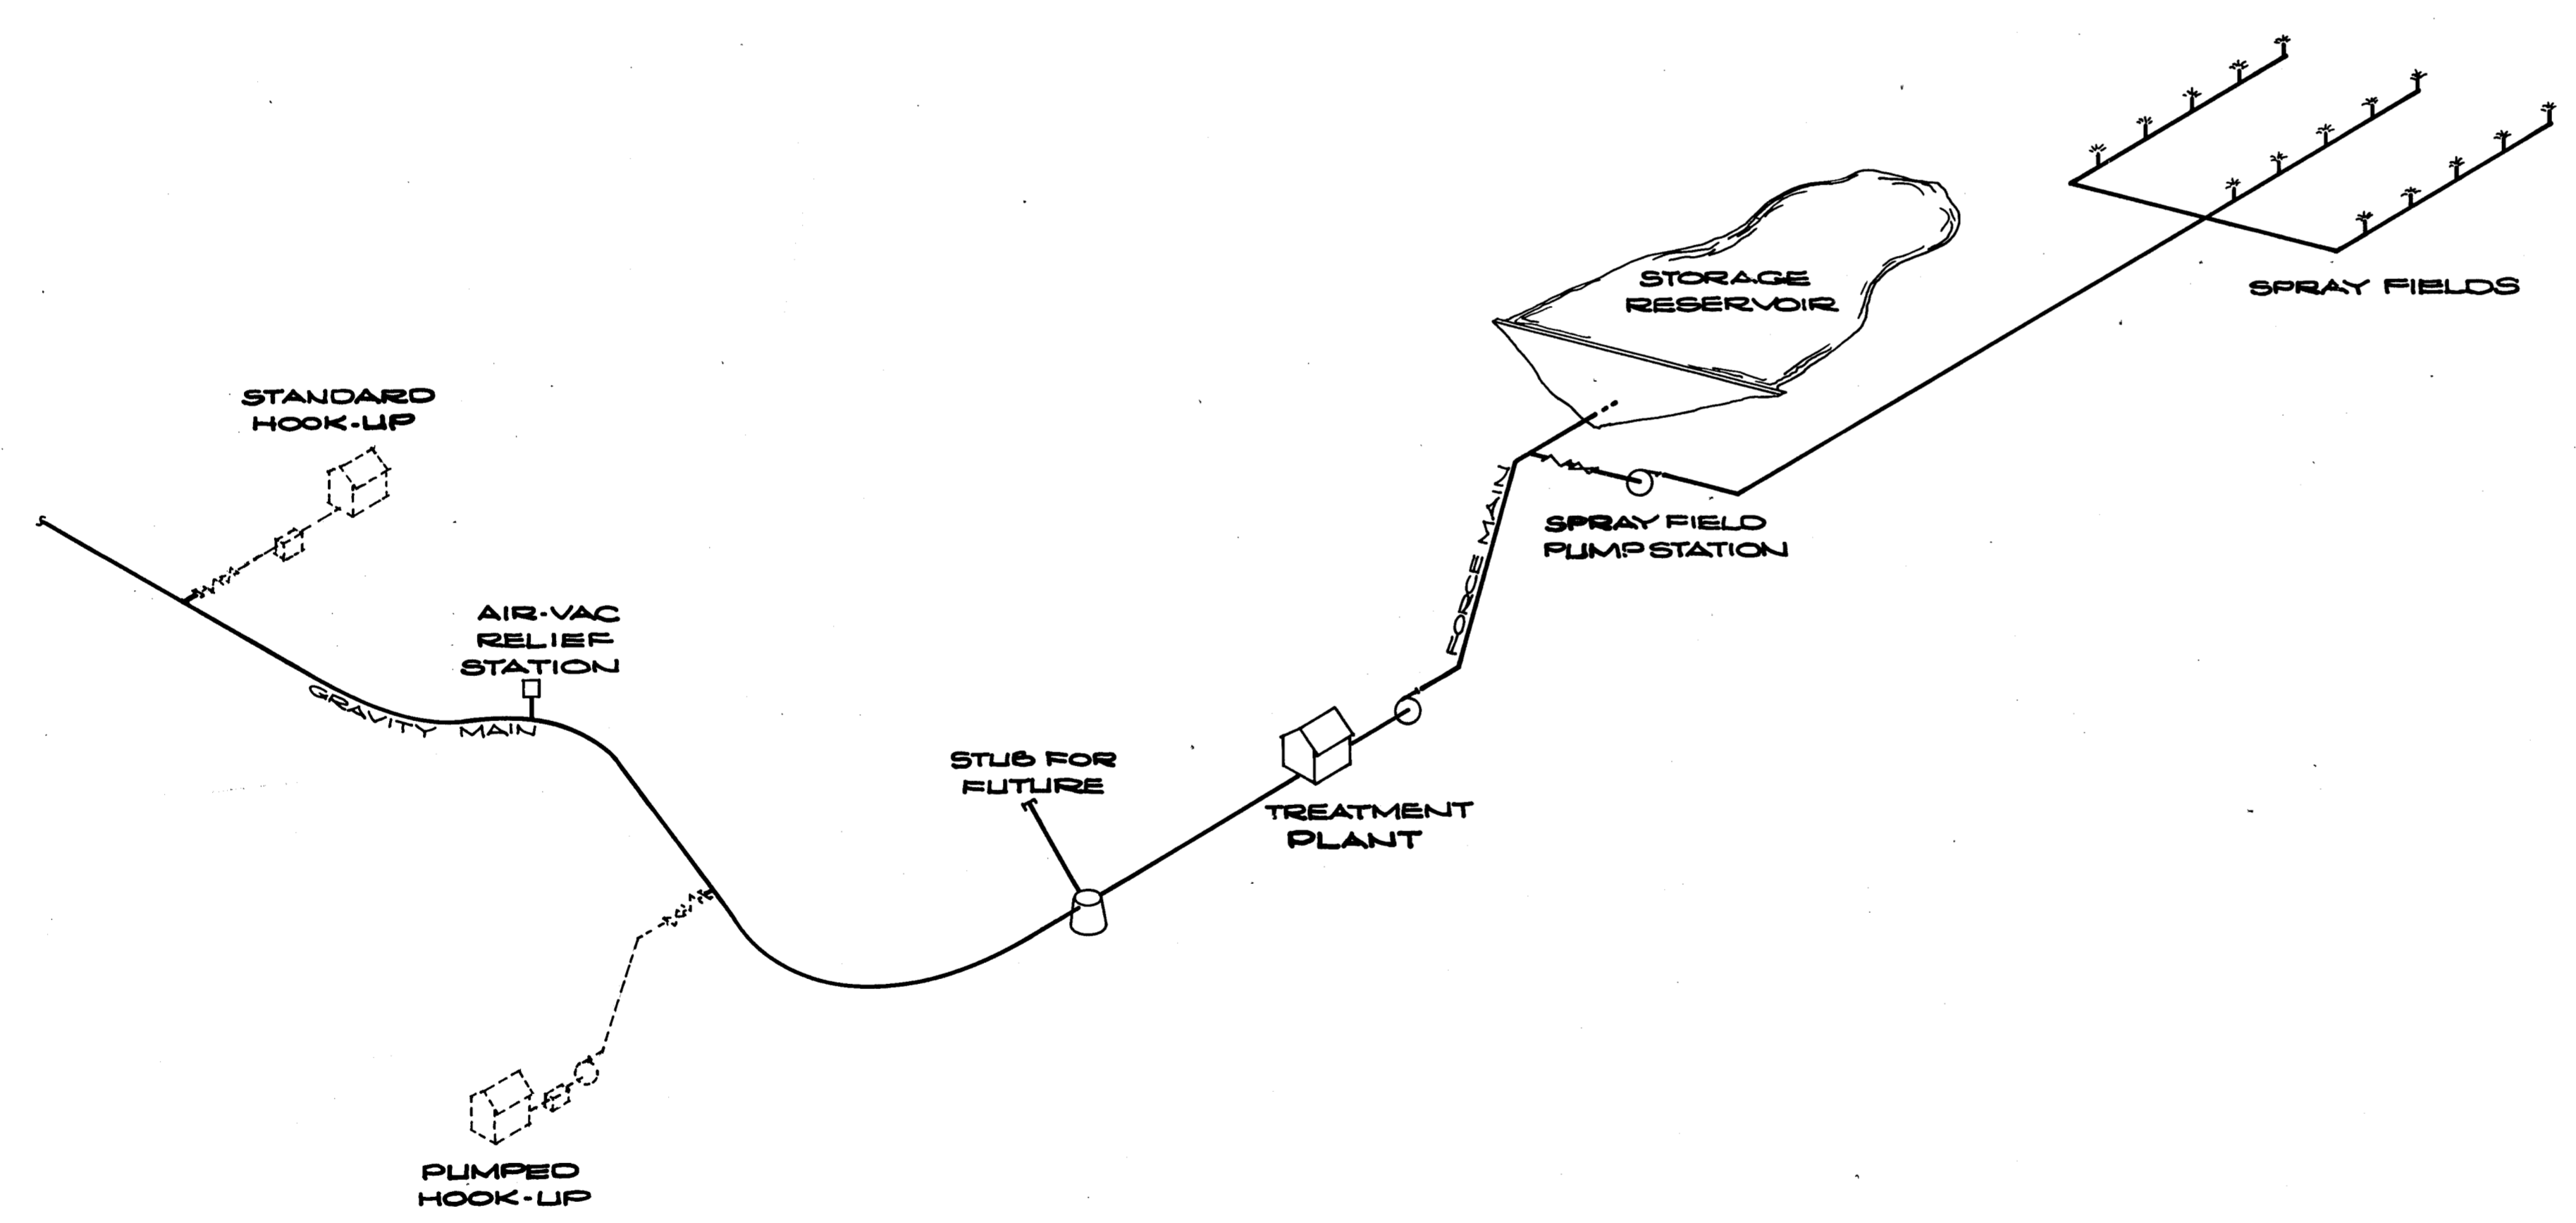

### SEWER SYSTEM SCHEMATIC

NO SCALE

DIERICHPOST REORDER NO. 10218


DRAWN BY: <u>R.S.</u> CHECKED: _____ SUBMITTED BY: <u>[Signature]</u> E. NO. <u>14774</u> EXPIRES: <u>9/31/09</u>	No. 14774 14774 14774	REVISION DATE DESCRIPTION BY APPD.
-------------------------------------------------------------------------------------------------------------------------	-----------------------------	------------------------------------

**WEATHERBY ASSOCIATES INC.**  
 ENGINEERING - SURVEYING - PLANNING  
 206 Peak Street, Jackson, CA. 95642  
 209-223-0381 209-754-1137


WALLACE LAKE ESTATES  
 UNIT NO. 1  
 CALAVERAS COUNTY, CALIFORNIA  
**SEWER SYSTEM SCHEMATIC**

SCALE: NONE	DATE: 2-10-08
FILE NO. <u>D-3345</u>	SHEET: 9-1
	OF 8



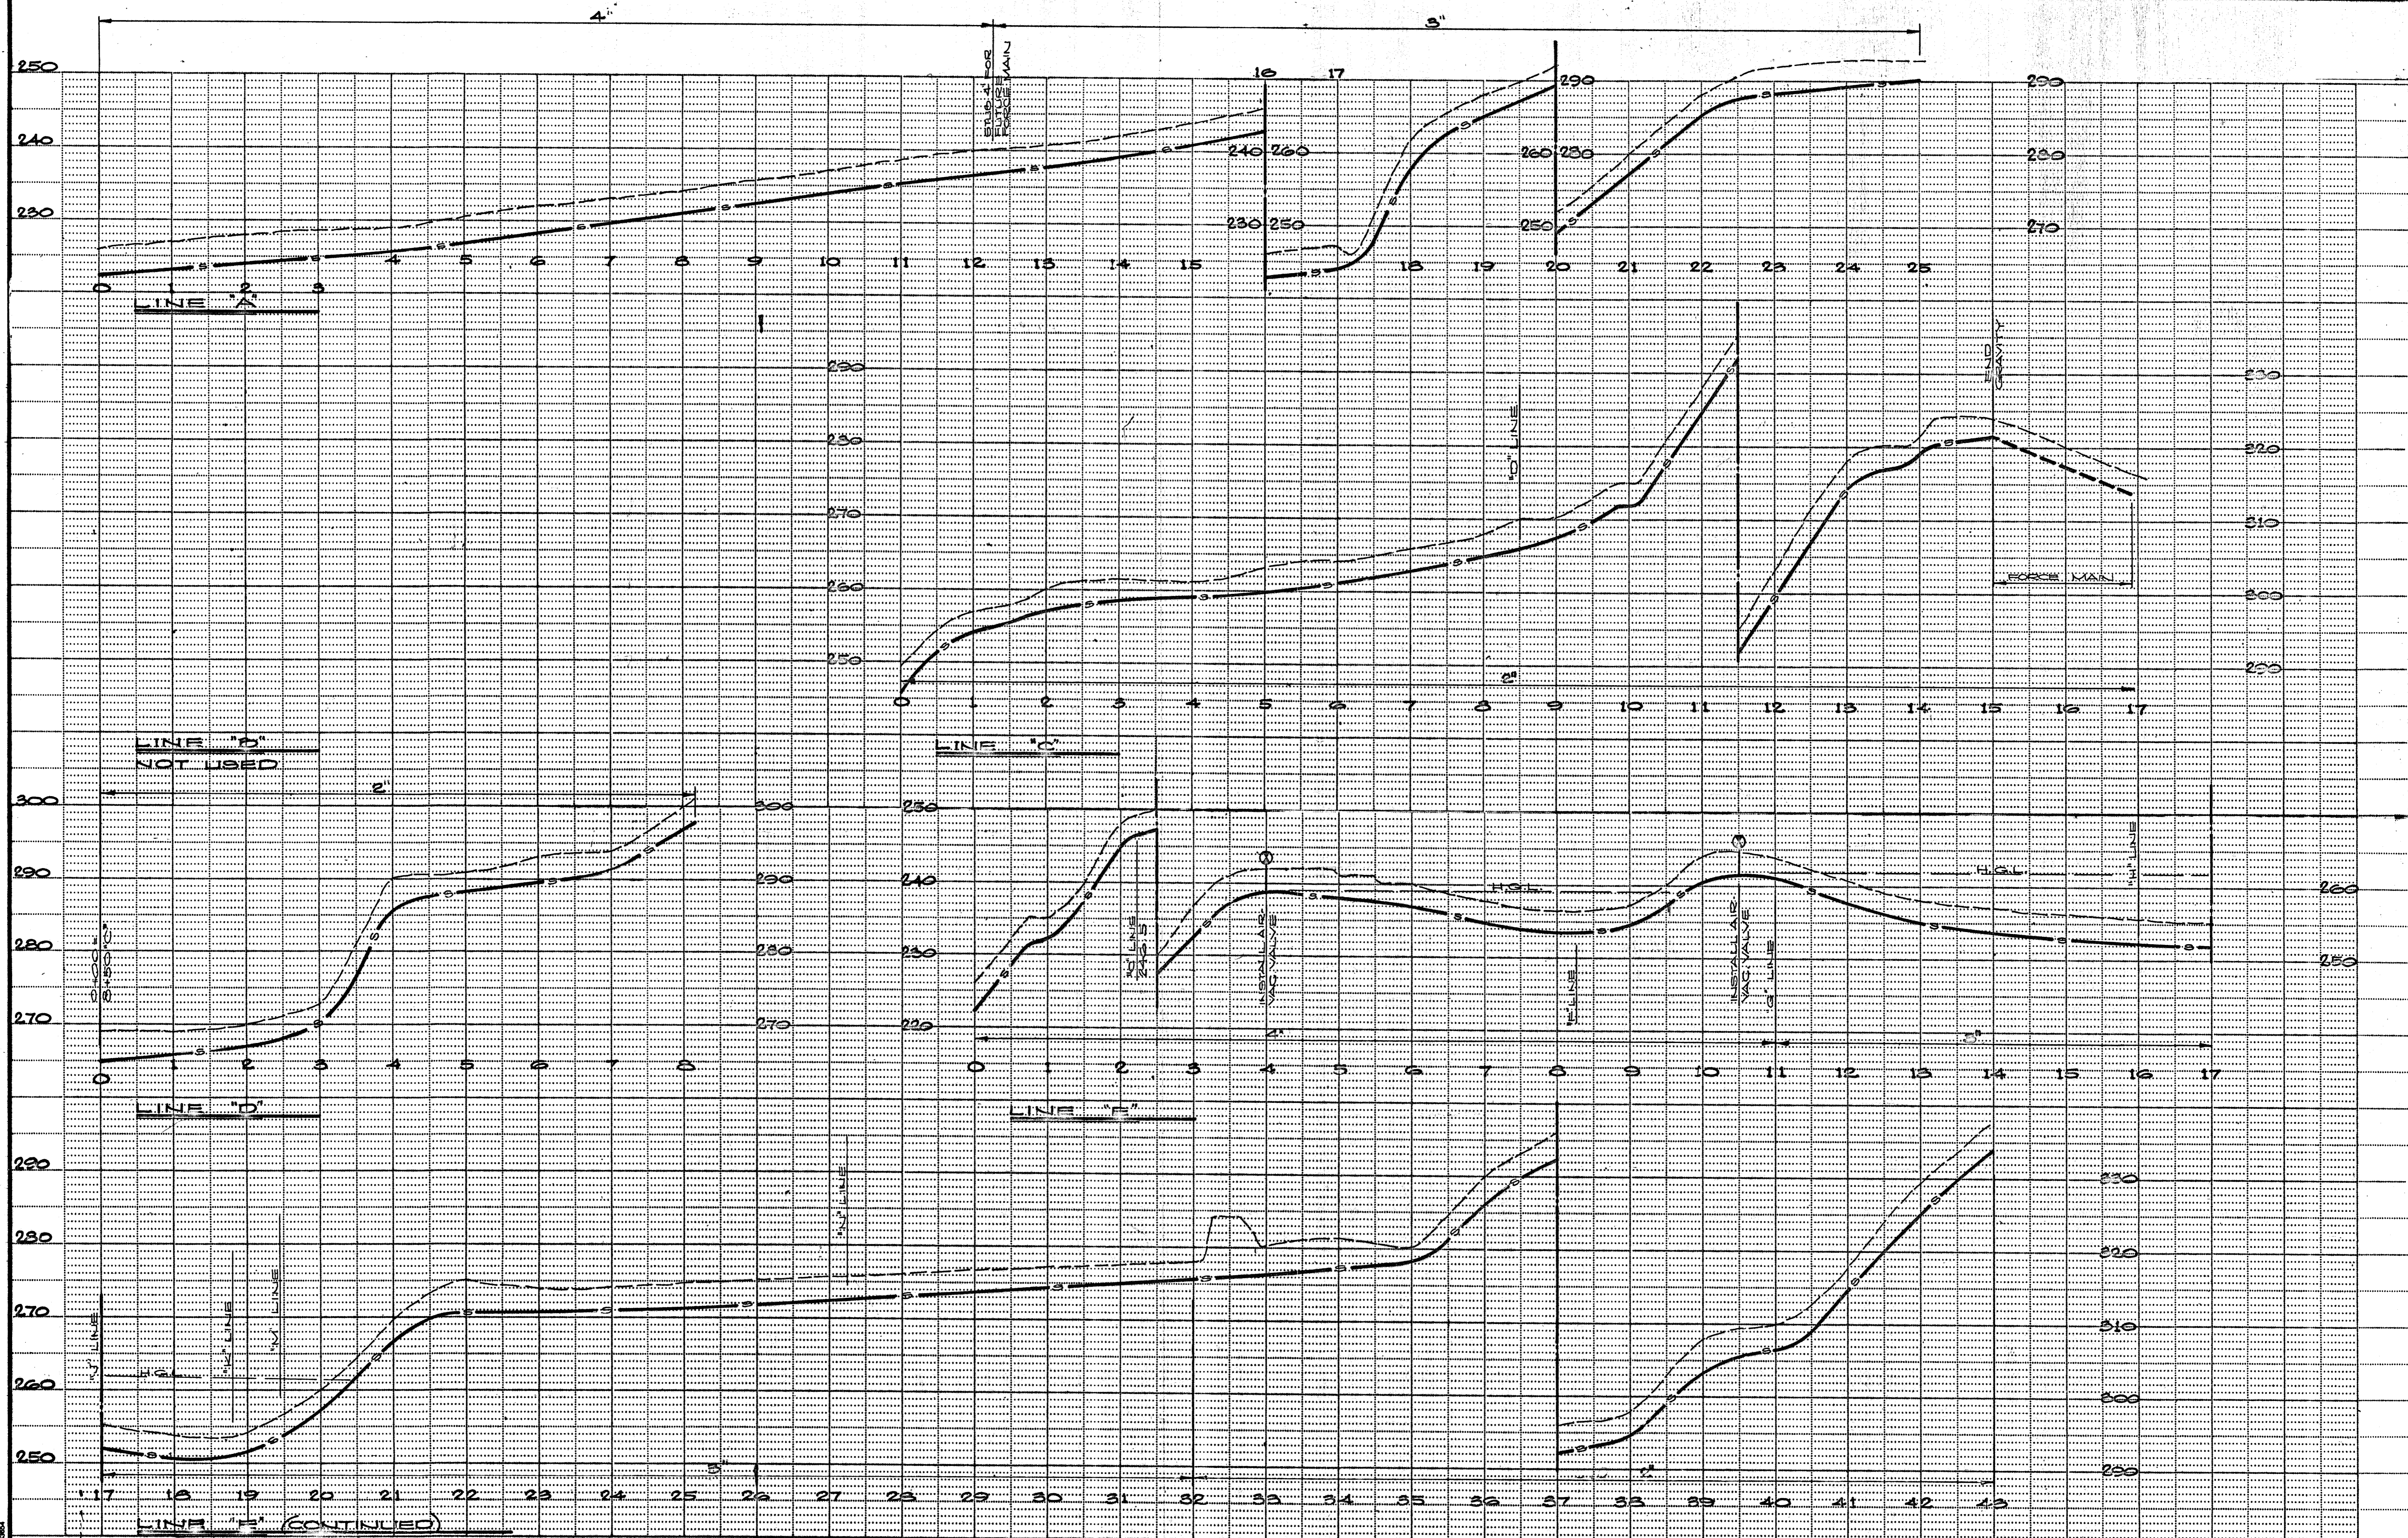


PREPARED BY: \_\_\_\_\_  
 DRAWN BY: RS. CHECKED: \_\_\_\_\_  
 SUBMITTED BY: *E. J. ...* C. E. NO. 1274  
 EXPIRES: 3-31-83  
 REVISION DATE: \_\_\_\_\_ DESCRIPTION: \_\_\_\_\_ BY: A.D.

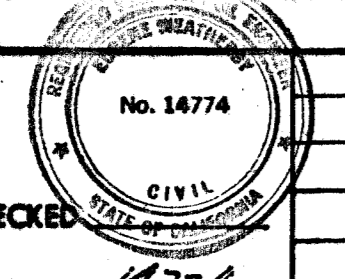

**WEATHERBY ASSOCIATES INC.**  
 ENGINEERING - SURVEYING - PLANNING  
 206 Peck Street, Jackson, CA. 95642  
 209-223-0381 209-714-1137

**WALLACE LAKE ESTATES**  
**UNIT NO. 1**  
 CALAVERAS COUNTY, CALIFORNIA  
**SEWER PROFILES**

DATE: 2-18-88  
 SCALE: 1" = 100' HORIZ. 1" = 10' VERT.  
 SHEET: 53  
 FILE NO.: D-3343

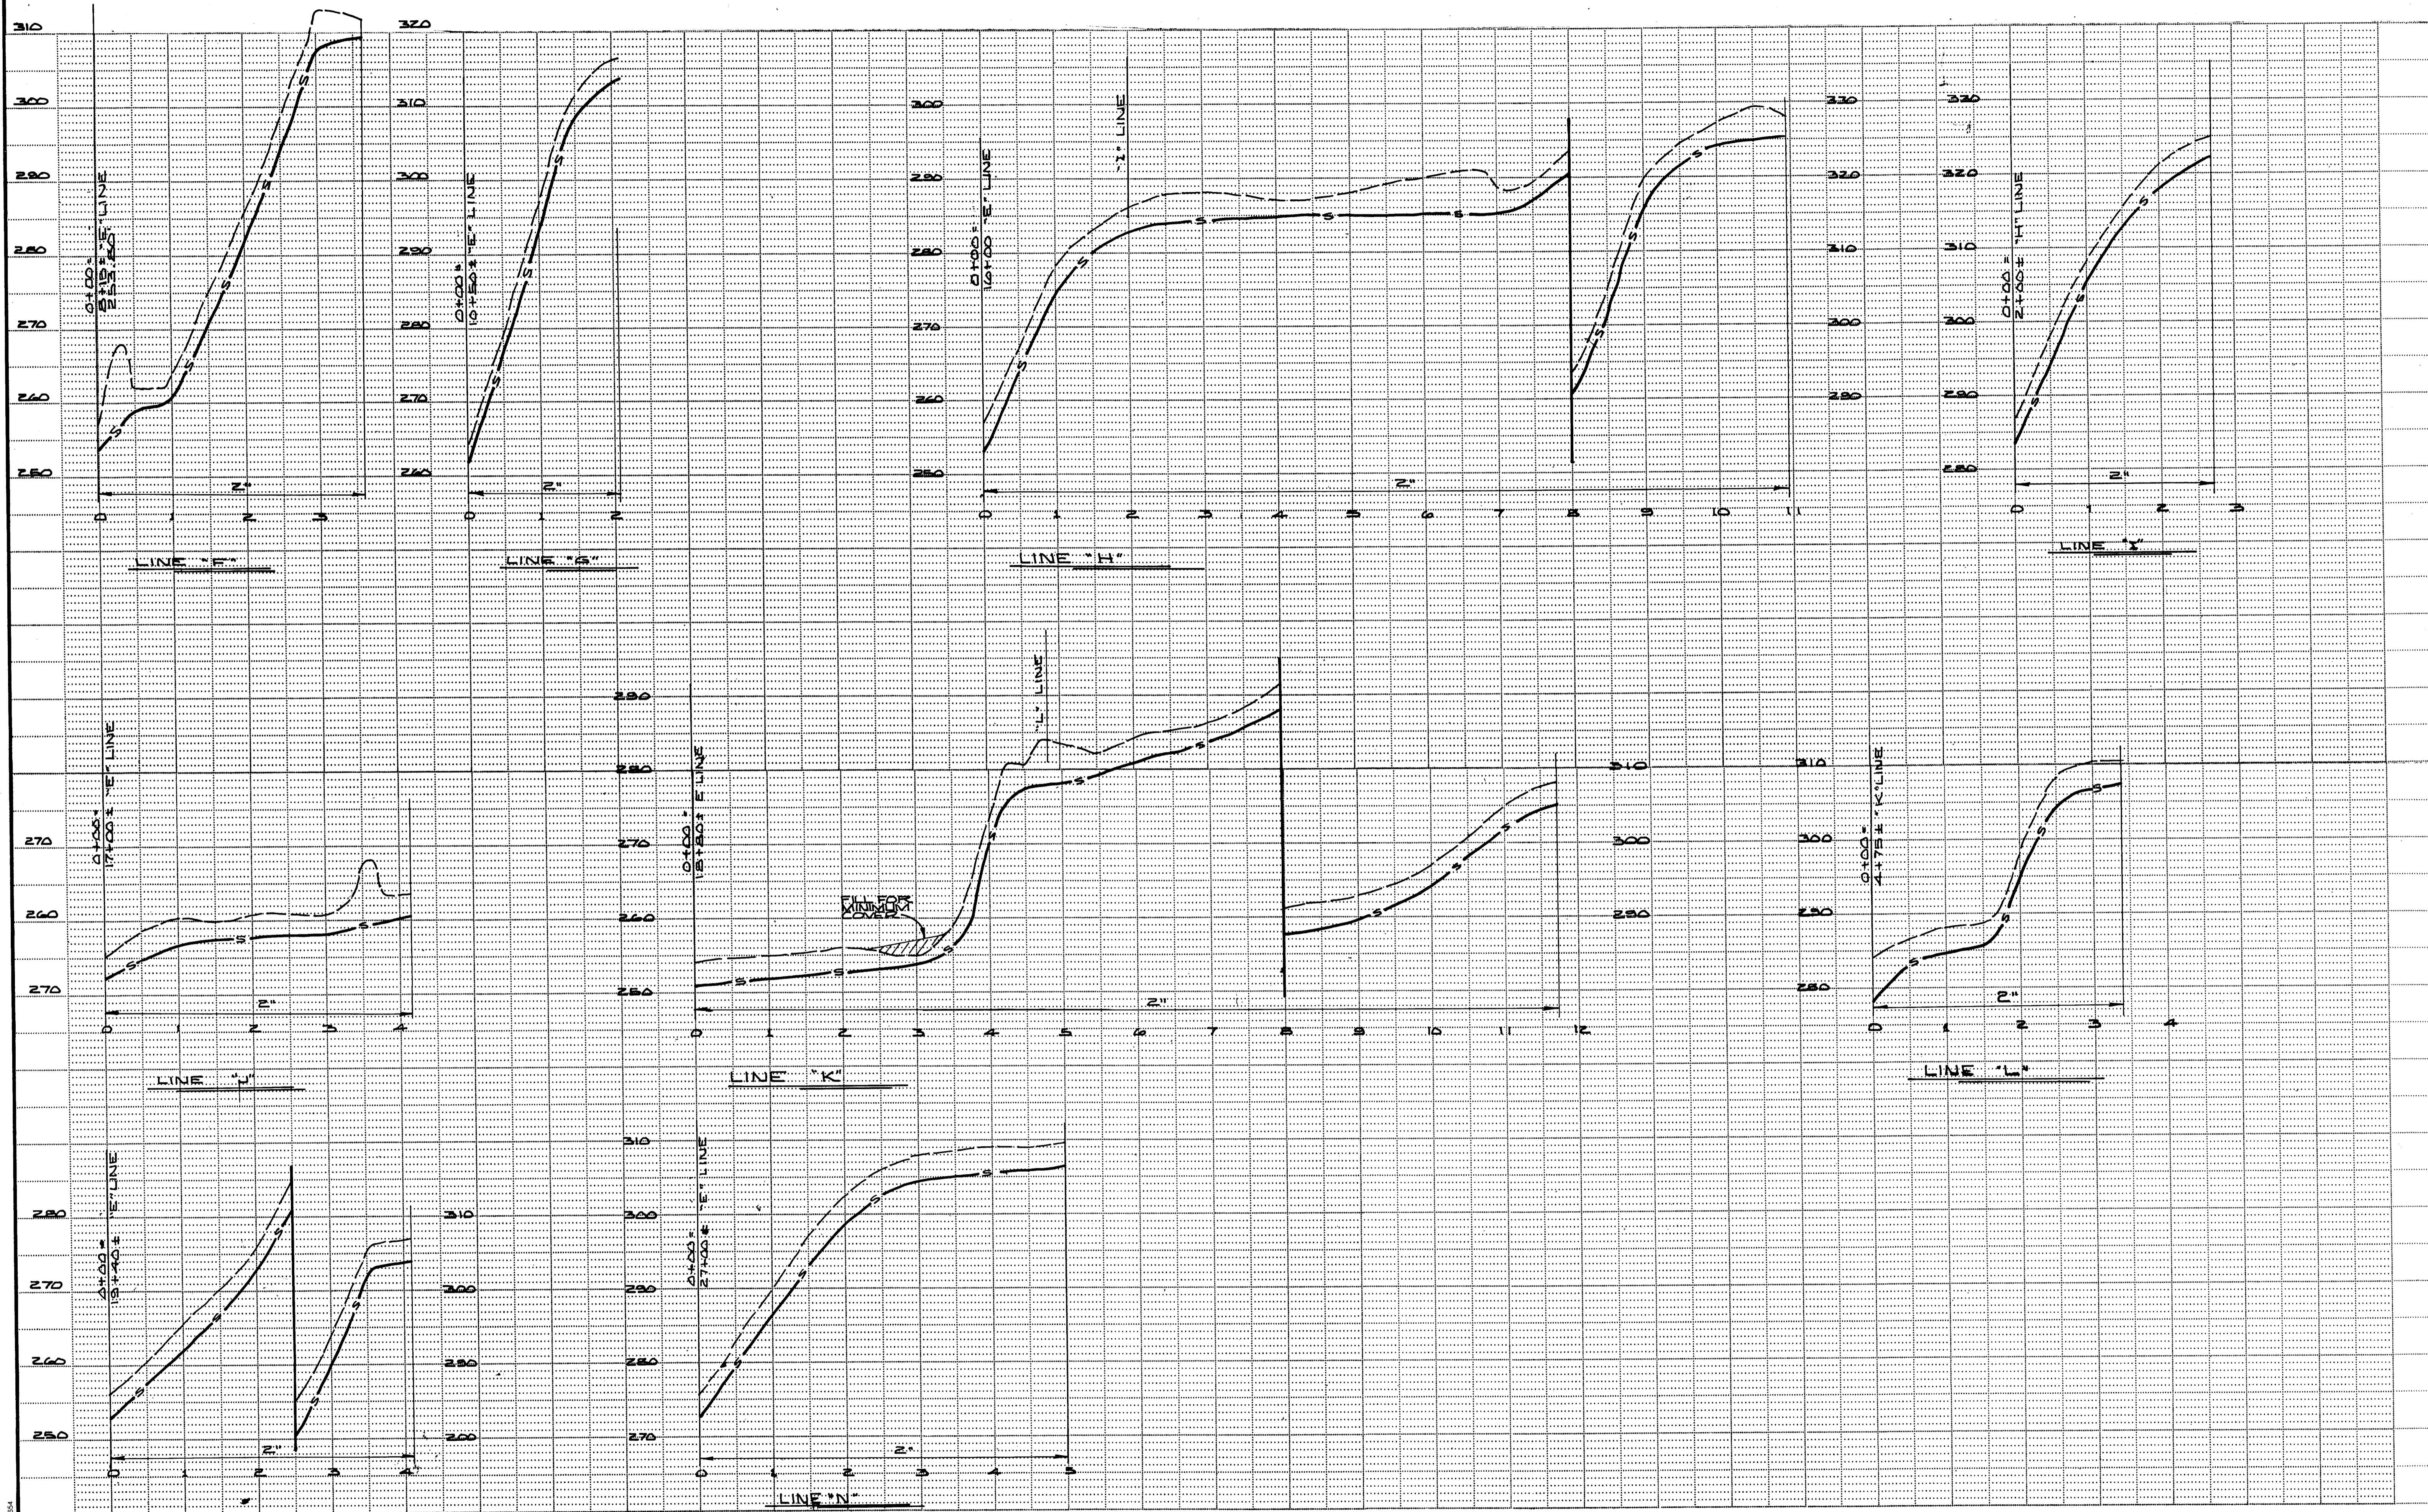

DIETRICHPOST REORDER NO. 0894


PREPARED BY: \_\_\_\_\_  
 DRAWN BY: RS CHECKED: \_\_\_\_\_  
 SUBMITTED BY: \_\_\_\_\_ C. E. NO. \_\_\_\_\_

REVISION	DATE	DESCRIPTION	BY	APPD.

**WEATHERBY ASSOCIATES INC.**  
 ENGINEERING - SURVEYING - PLANNING  
 206 Peak Street, Jackson, CA. 95642  
 209-223-0381 209-754-1137

**WALLACE LAKE ESTATES**  
 UNIT No 1  
 CALAVERAS COUNTY, CALIFORNIA  
**SEWER PROFILES**

DATE: 2-18-85  
 SHEET: S-4  
 SCALE: 1"=100' HORIZ  
1"=10' VERT.  
 FILE NO. D-3345 OF 5

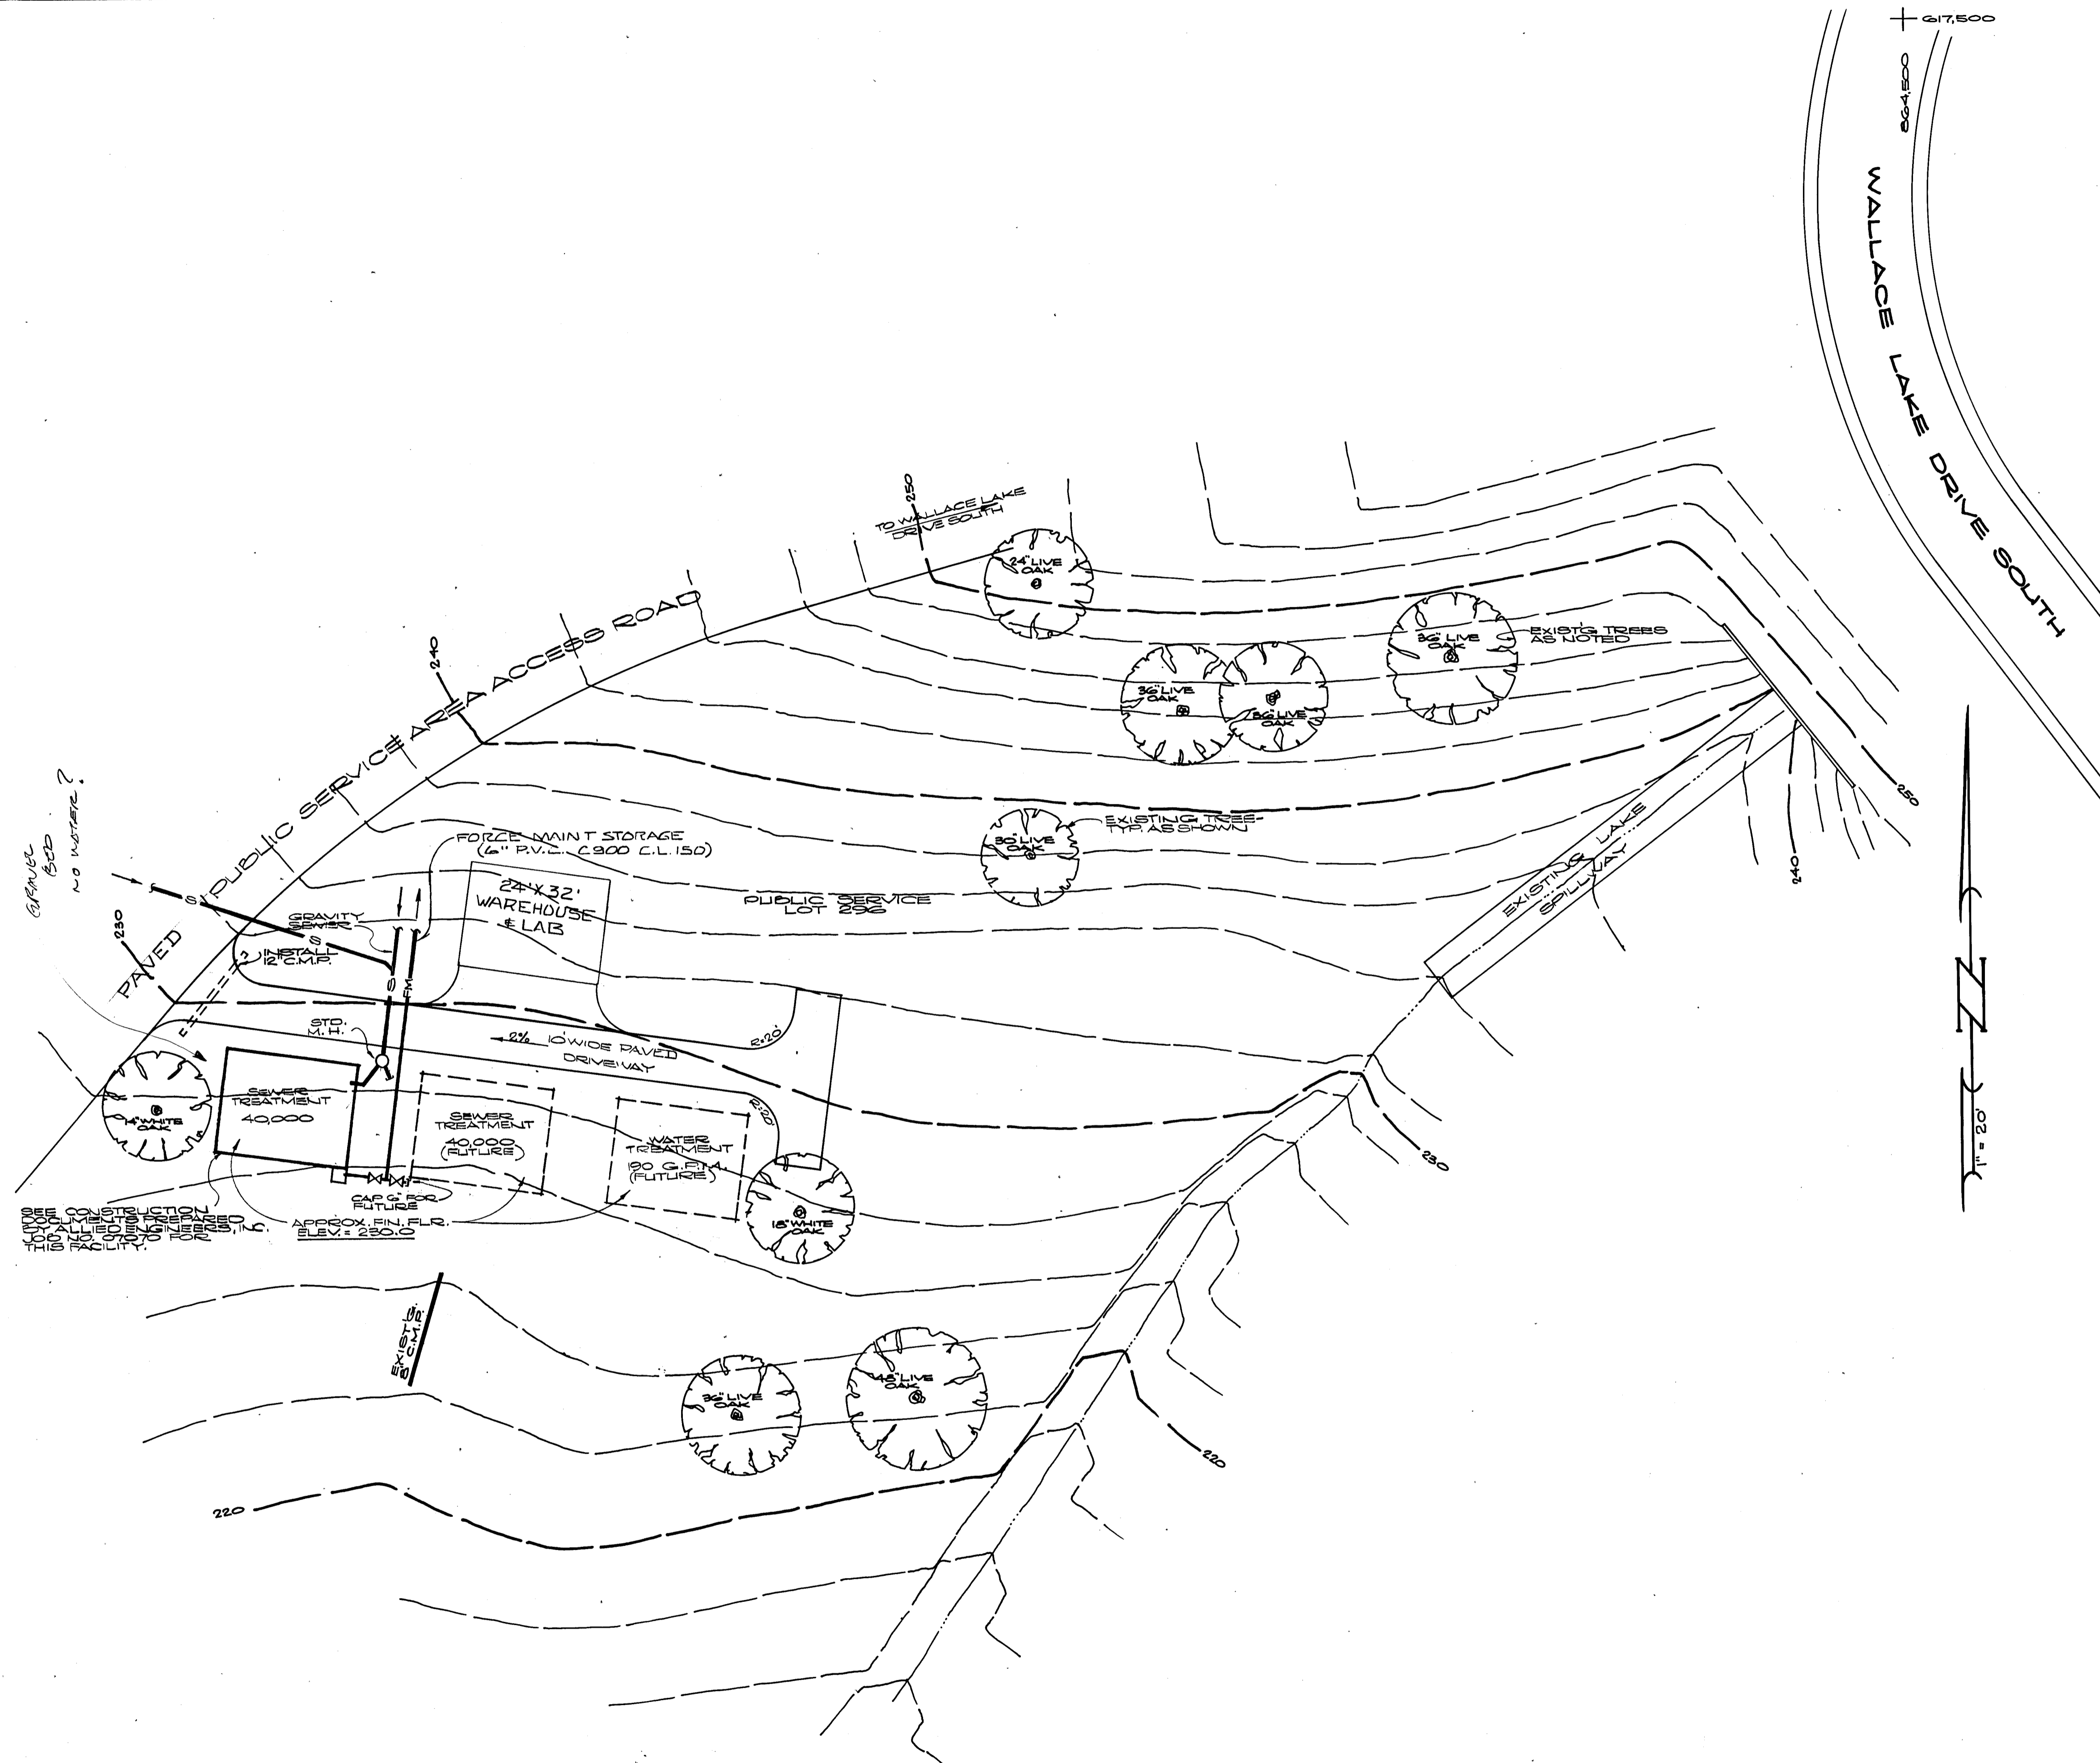

- WAREHOUSE**
1. OFFICE SPACE W/AC
  2. WORKBENCH
  3. SINK
  4. METAL STORAGE RACKS & BINS.
  5. LAB & EQUIPMENT TO RUN REGIONAL BOARD LAB TESTS.

**PARTIAL SITE PLAN** 1" = 20'

DRAWN BY: <u>R.S.</u> CHECKED: <u>[Signature]</u> SUBMITTED BY: <u>[Signature]</u> C. E. NO. <u>14774</u> EXPIRES: <u>3-31-89</u>					
	REVISION	DATE	DESCRIPTION	BY	APPD.

**WEATHERBY ASSOCIATES INC.**  
 ENGINEERING - SURVEYING - PLANNING  
 206 Peck Street, Jackson, CA, 95642  
 209-223-0381 209-754-1137

**WALLACE LAKE ESTATES  
 UNIT NO. 1**  
 CALAVERAS COUNTY, CALIFORNIA  
**SEWER TREATMENT AREA**

DATE	2-18-88
SHEET	55
SCALE:	NOTED
FILE NO.	D-3345
	Of 8

DIETRICH-POST, RECORDER NO. 93318



- LEGEND:**
- 100' CONTOUR LINE
  - WATER CONTROL STRUCTURE
  - GATE VALVE
  - INLET-OUTLET
  - GATE STRUCTURE
  - INLET-OUTLET
  - GATE STRUCTURE

DIETRICH-HOST REGISTER NO. 10218

NO. 14775

DRAWN BY: R.S. CHECKED: \_\_\_\_\_

SUBMITTED BY: [Signature] C. E. NO. 14774 EXPIRES 3-31-89

REVISION	DATE	DESCRIPTION	BY	APPD.
1	1/22/81	SOUTH SPRAY FIELD ADDED	<u>[Signature]</u>	<u>[Signature]</u>

**WEATHERBY ASSOCIATES INC.**  
 ENGINEERING - SURVEYING - PLANNING  
 206 Peek Street, Jackson, CA. 95642  
 209-223-0381 209-754-1137

**WALLACE LAKE ESTATES**  
**UNIT NO. 1**  
 CALAVERAS COUNTY, CALIFORNIA  
**STORAGE RESERVOIR & SPRAY FIELD**

DATE: 2-18-88  
 SHEET: 50  
 SCALE: 1" = 50'  
 FILE NO. D-3345  
 OF 3







